

These drawings are the property of Moduspace Ltd and must not be used without the Directors permission for any purpose other than which they are intended

- Emergency Light
- C.U Board
- Fan (Extractor)
- Int Bulk head light
- Isolator switch
- Light Switch
- Pull Switch
- Water heater
- Double socket (low)


- Single 1500 tube
- 6000 Strip Heater
- H-level fan heater
- 2kw Convactor heater
- Thermostat
- 2kw Convactor heater + socket right
- Double socket (high)

# MODUSPACE

©2004

DETAILS OF REVISION: xxx DATE: ??/??	CLIENT: <b>Mowlem plc</b>
DRAWING TITLE: <b>Ground Floor Production</b>	
DRAWN BY: <b>WNS MA</b>	CHECKED BY: <b>MA</b>
SCALE: <b>1/100</b>	
DRAWING NO: <b>02-12-OFFICE-108</b>	
REV: --	

BURTS WHARF  
CRABTREE MANORWAY NORTH  
BELVEDERE  
KENT  
DA17 6LJ  
TEL: 020 8311 707  
FAX: 020 8312 99

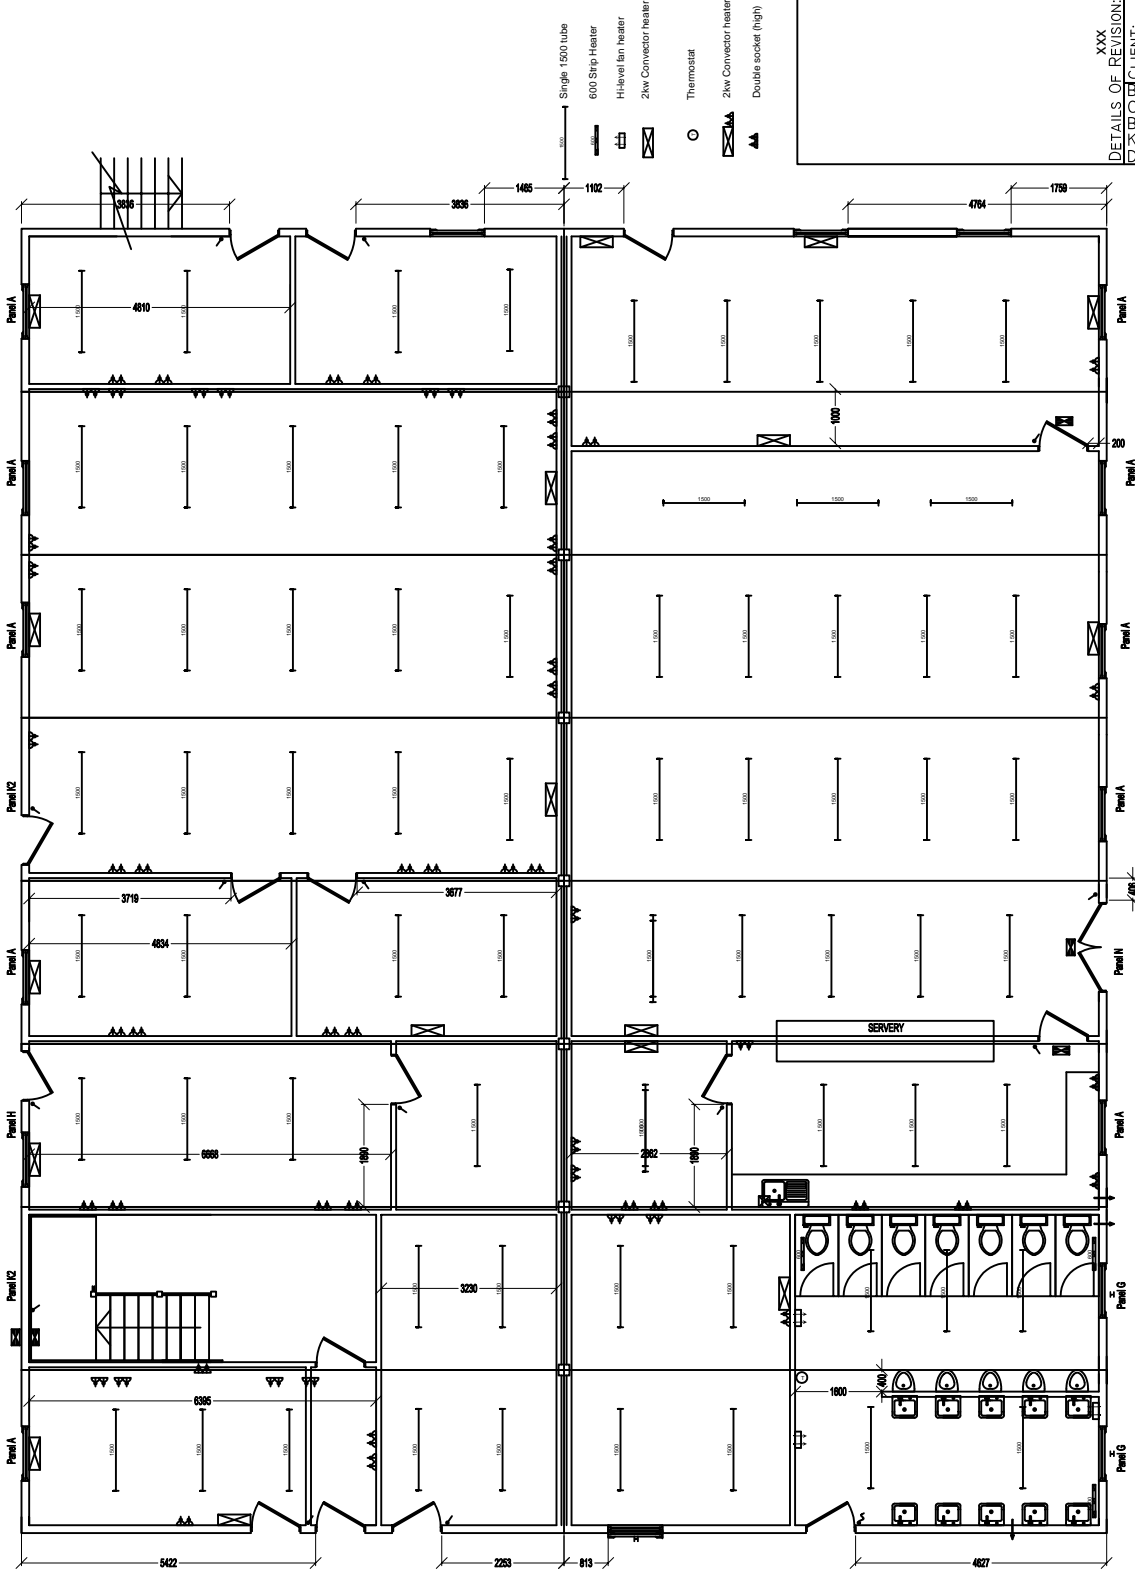

Ground Floor Plan @ 1/100

This document was created with Win2PDF available at <http://www.win2pdf.com>.  
The unregistered version of Win2PDF is for evaluation or non-commercial use only.